
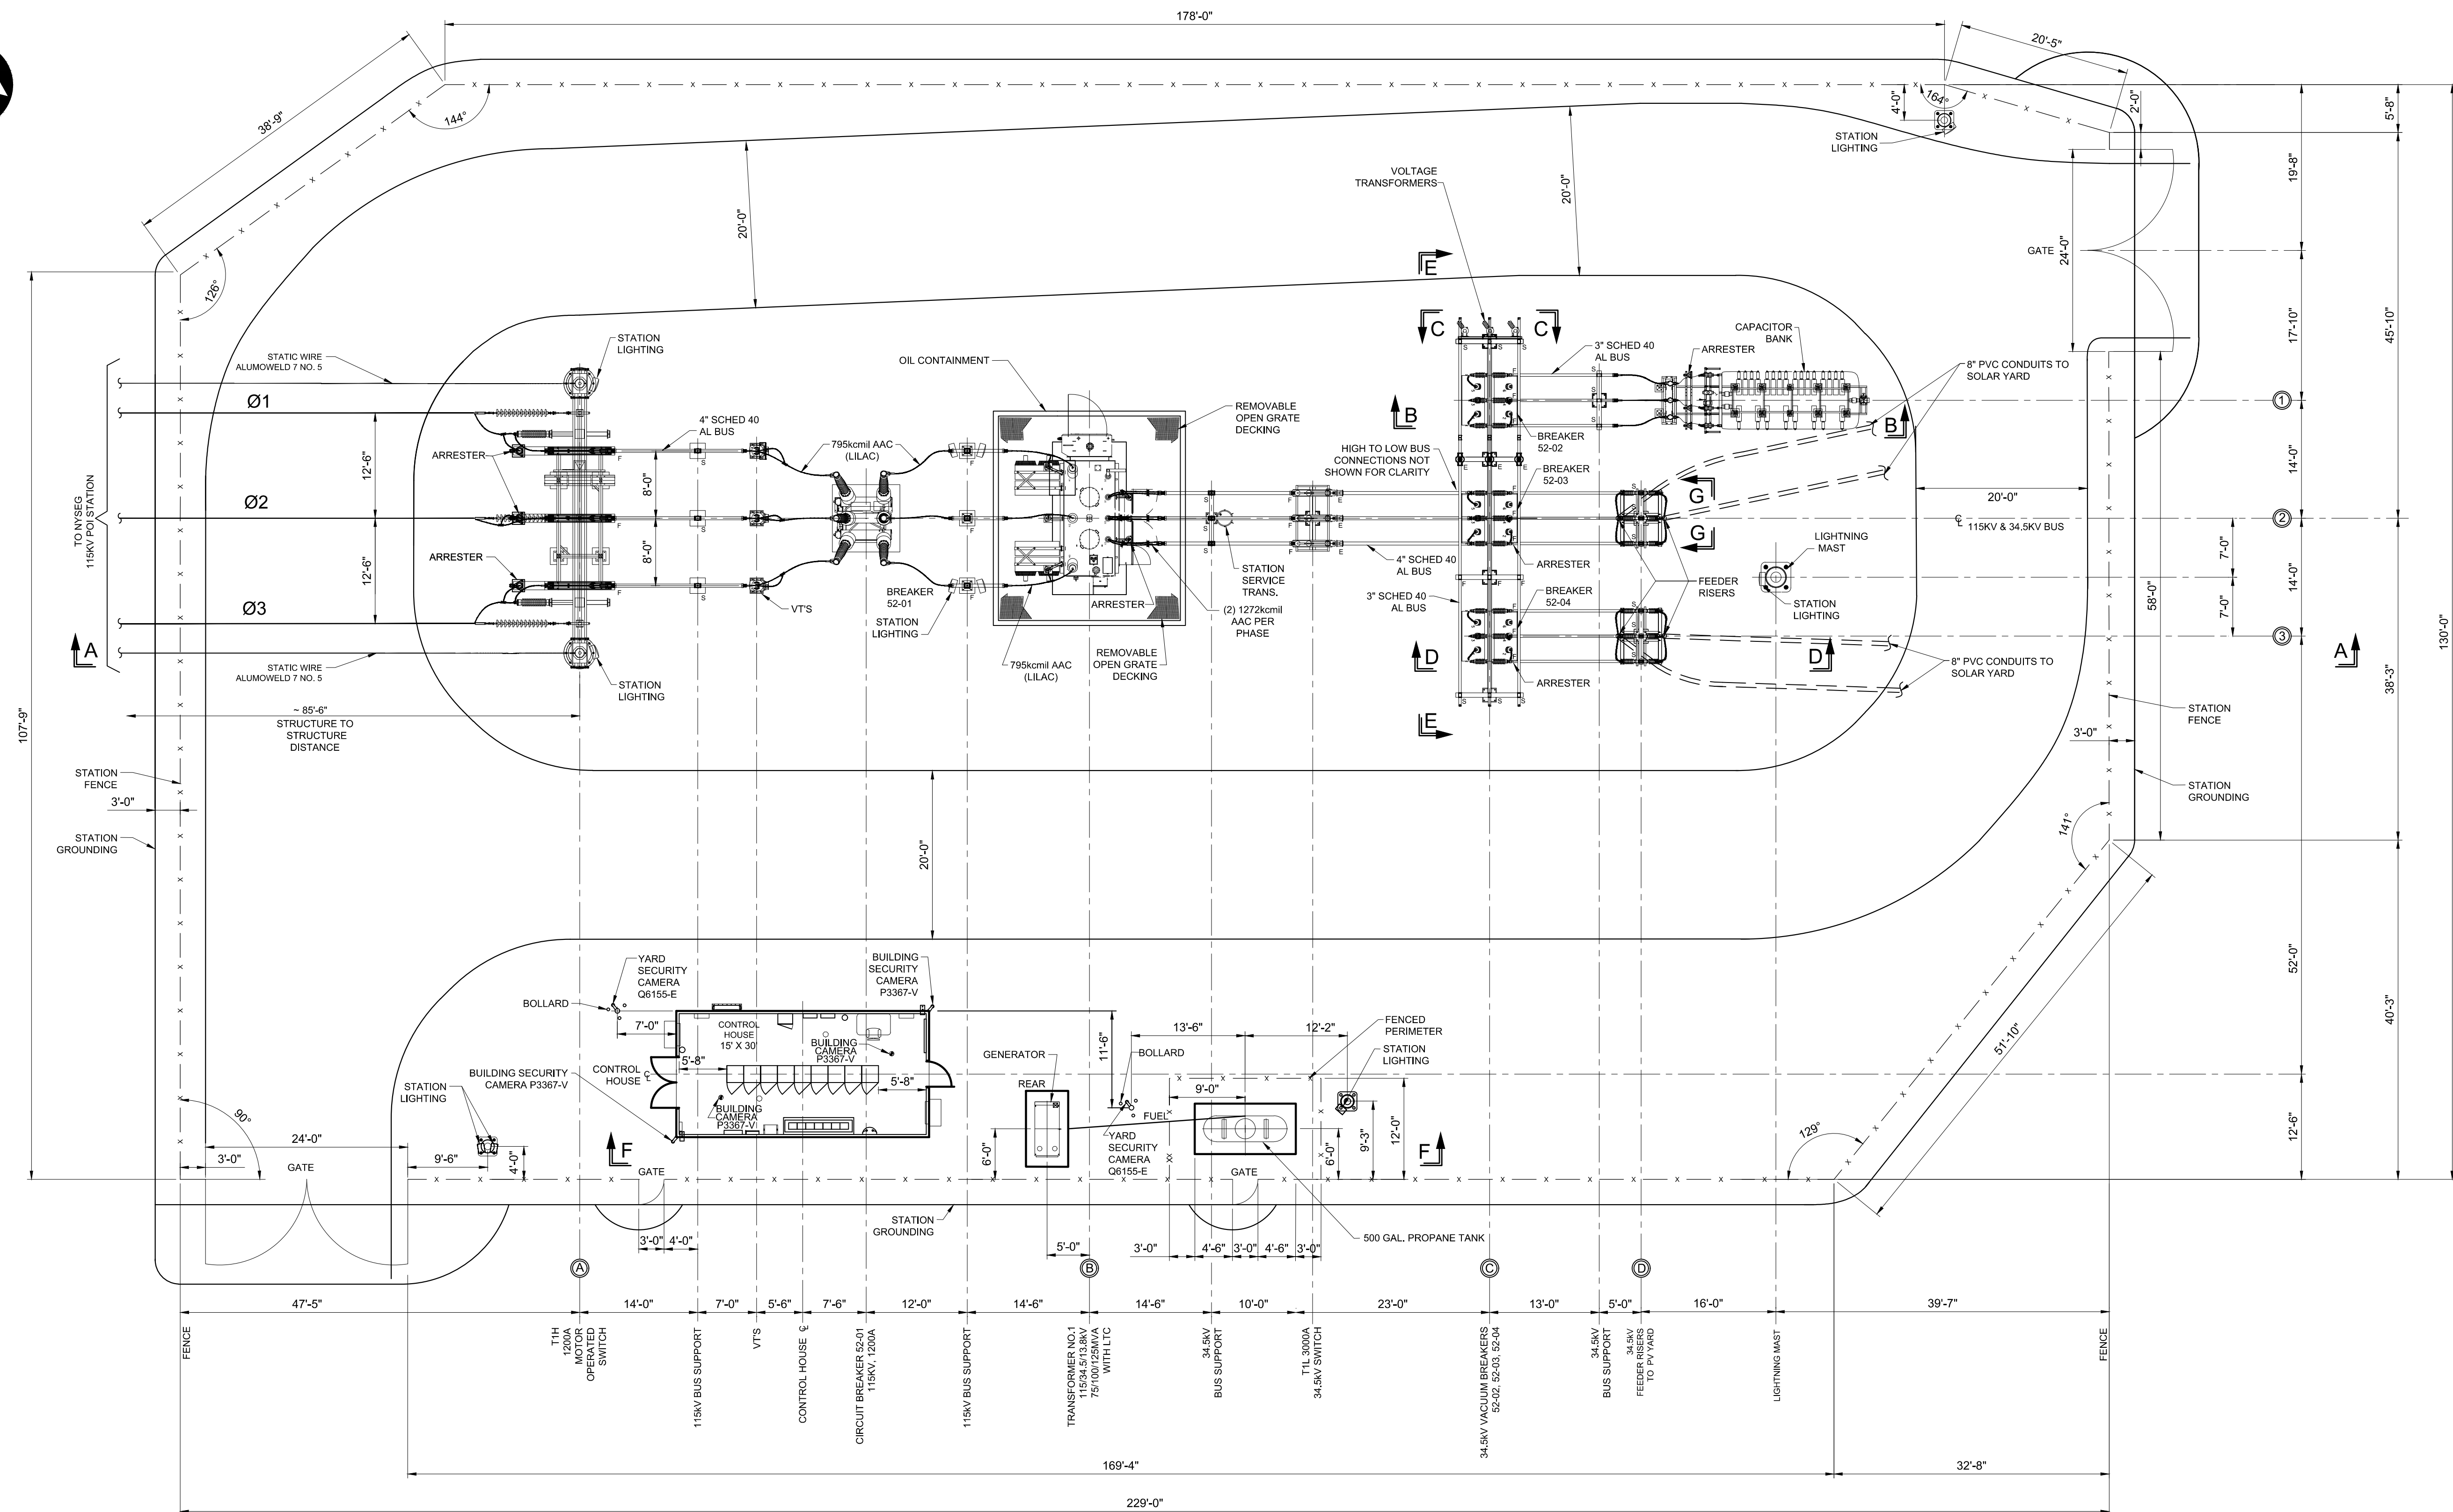


Appendix 7-6

Collector Substation Layout

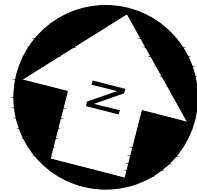

PRELIMINARY
NOT FOR CONSTRUCTION

UNDER NEW YORK STATE EDUCATION LAW ARTICLE 145 (ENGINEERING), SECTION 7209 (2), IT IS A VIOLATION OF THE LAW FOR ANY PERSON, UNLESS ACTING UNDER THE DIRECTION OF A LICENSED PROFESSIONAL ENGINEER, TO ALTER THIS DOCUMENT.

PE STAMP:

KEY PLAN:

REVISIONS:

NO.	DATE	DESCRIPTION
0	07/15/2021	ISSUED FOR PERMIT
1	09/17/2021	ISSUED FOR PERMIT
2	10/27/2021	ISSUED FOR PERMIT

PROJECT TITLE:	
----------------	--

BROOKSIDE SOLAR
COLLECTION
SUBSTATION
115KV-34.5KV

PROJECT LOCATION:

TOWNS OF BURKE AND
CHATEAUGAY, NY

SHEET TITLE & DESCRIPTION:

GENERAL ARRANGEMENT

OVERALL ELECTRICAL PLAN

PROJ	422299
NUM:	

DES: D. FARRELL

DWN: D. FARRELL

CHK: C. PASCALE

APV: C. PASCALE

DATE: 04/02/21

SCALE AT 22" x 34":

$$3/32'' = 1'-0''$$

SHEET NO:
HV-P.01.01

REV:
2